



ANNEXURE C FLOOR PLAN

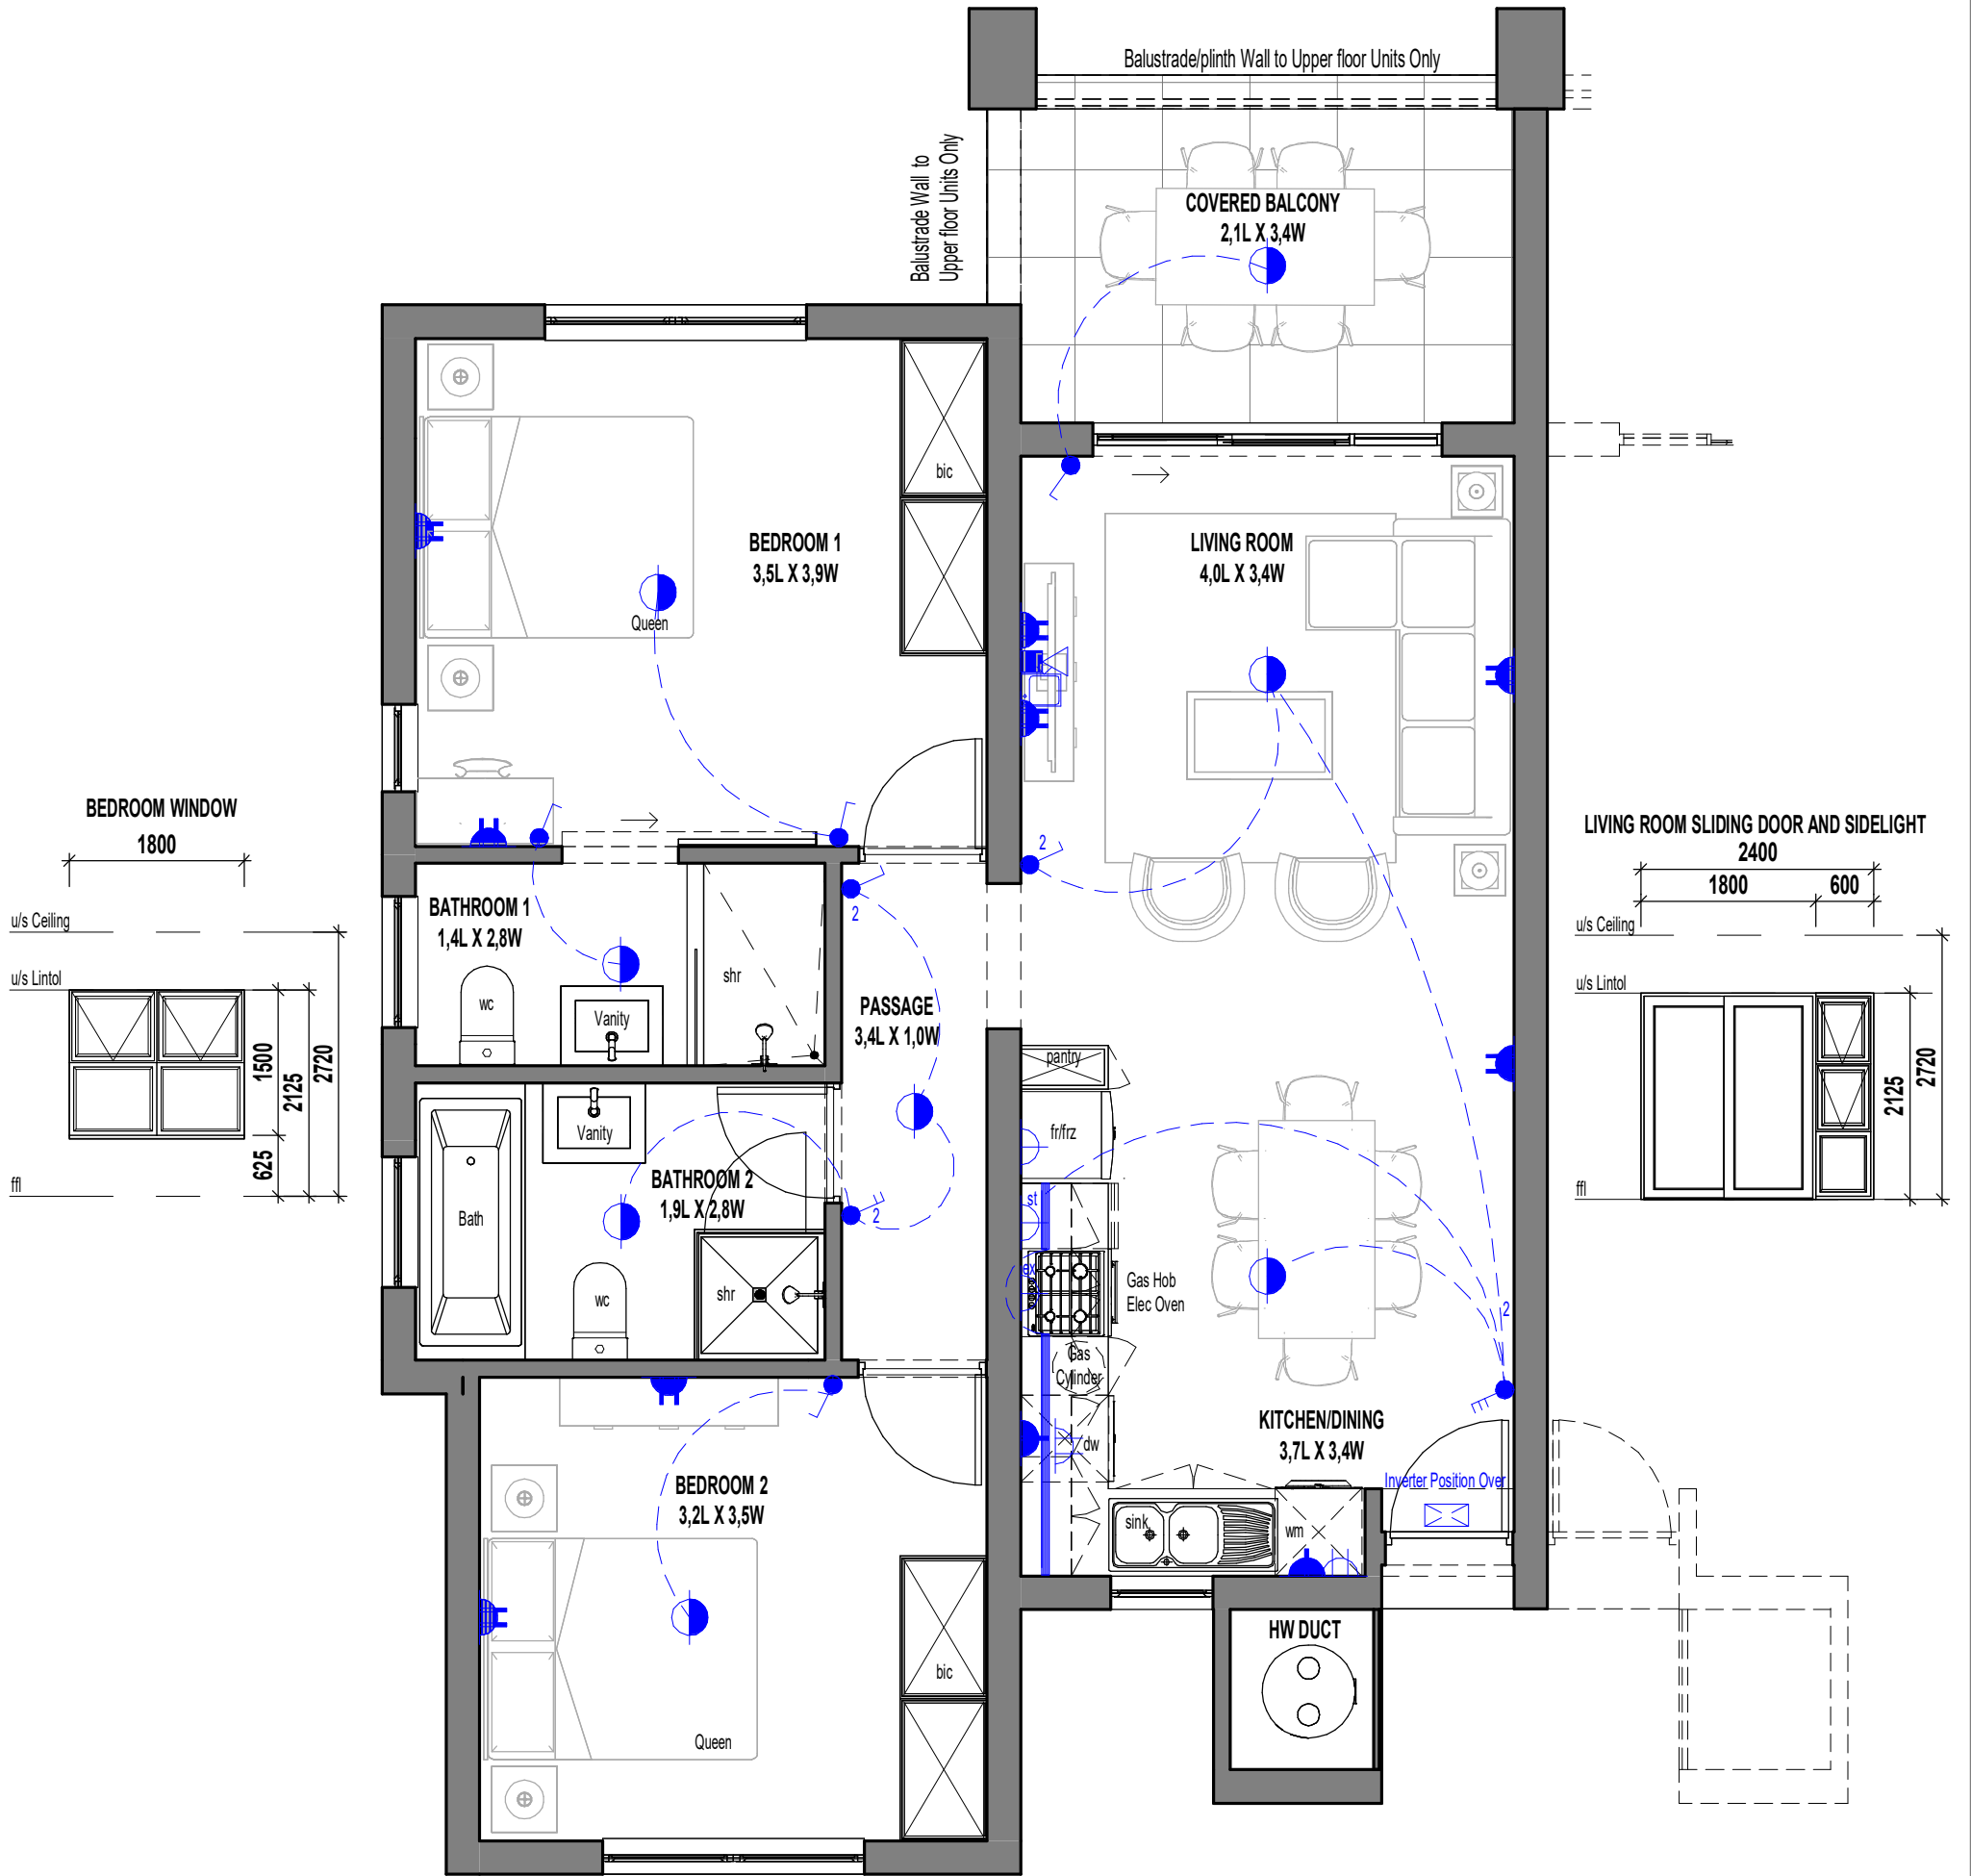

2 Bedroom - 2 Bathroom

SCALE 1:50

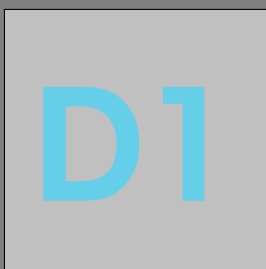

ELECTRICAL LEGEND

- | | | | | | |
|--|--|--|---|--|--------------------|
| | Surface Mounted LED Fitting | | Single Plug Point (300mm Above FFL) | | Distribution Board |
| | External Wall Mounted LED Light Fitting | | Double Plug Point (300mm Above FFL) | | TV Point |
| | LED Strip Light Fitting (u/s - Eye levels - Kitchen) | | Single Plug Point (150mm Above Counter) | | Fibre / Data Point |
| | Single Light Switch | | Double Plug Point (150mm Above Counter) | | Inverter |
| | Double Light Switch | | Stove Isolator (Above Counter) | | |
| | Triple Light Switch | | Extractor Plug (High Level) | | |
| | Two-Way Light Switch | | | | |

AREA TYPE D1

Floor Area	74.37 m ²
Cov Patio/Balcony	8.74 m ²
Total	83.11 m ²

* The areas are approximate and shall vary from the areas reflected on the sectional title plan