
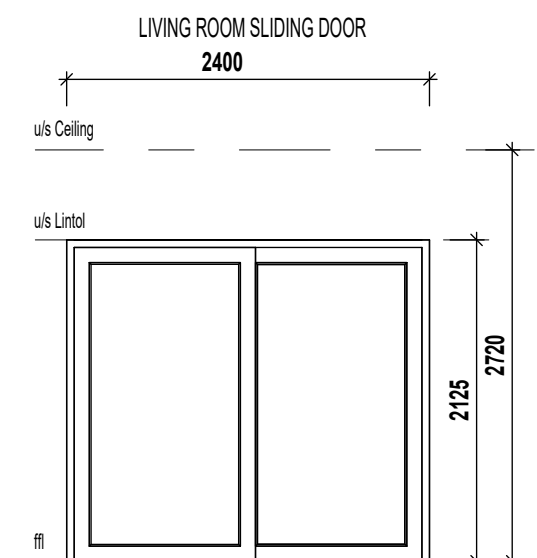
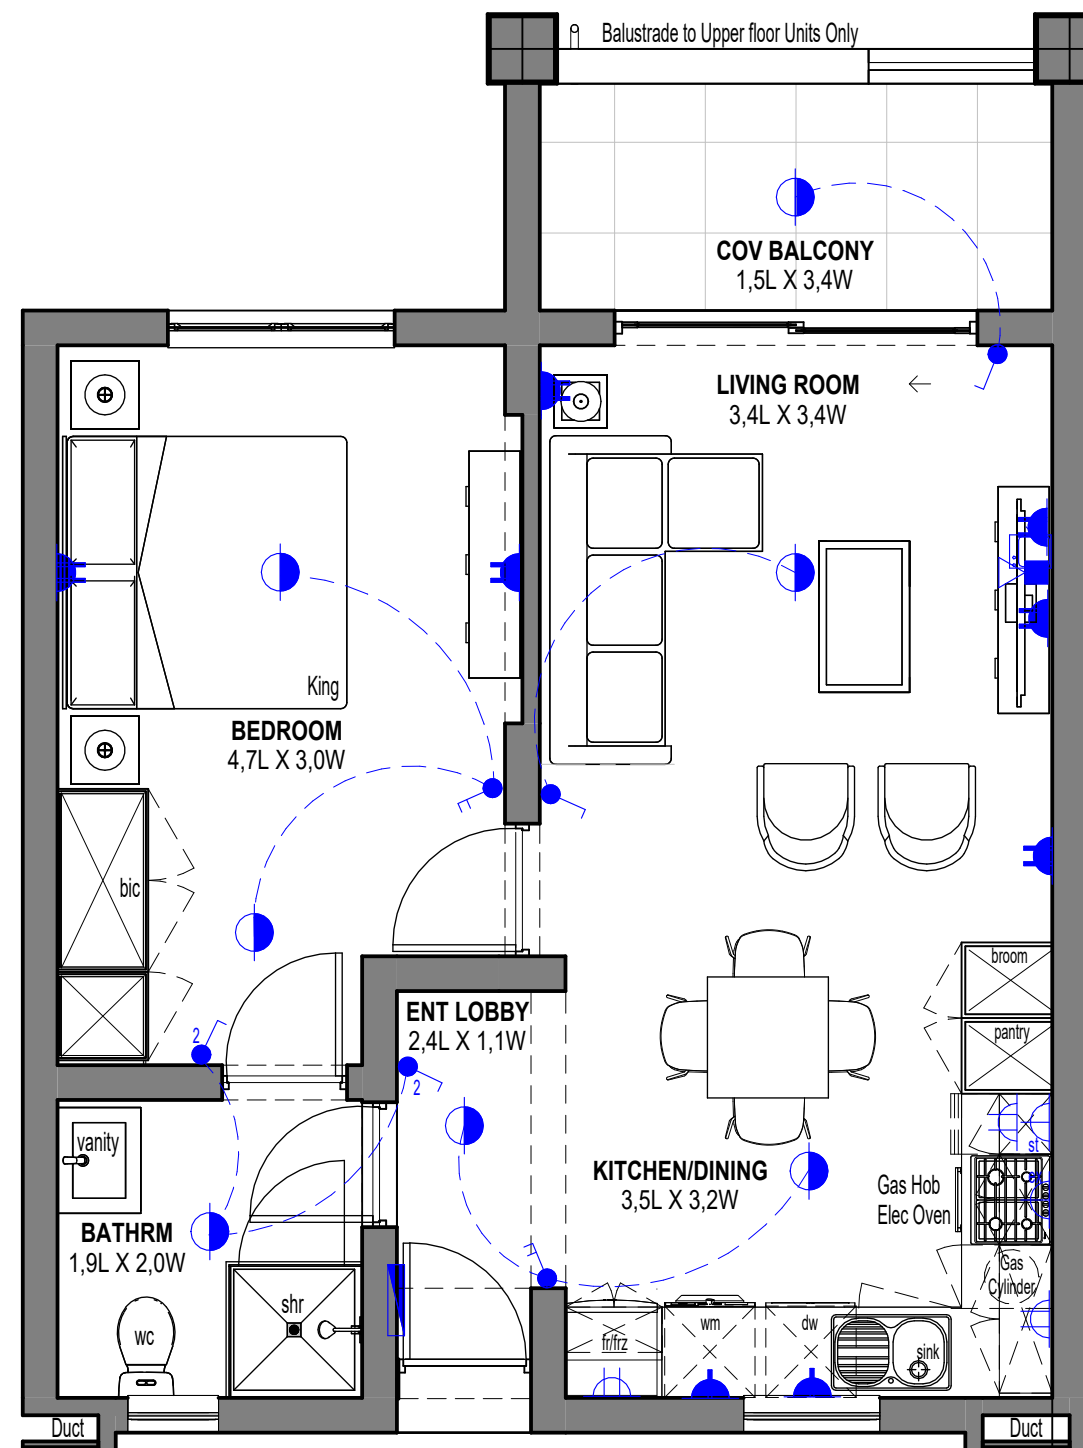


ANNEXURE C FLOOR PLAN

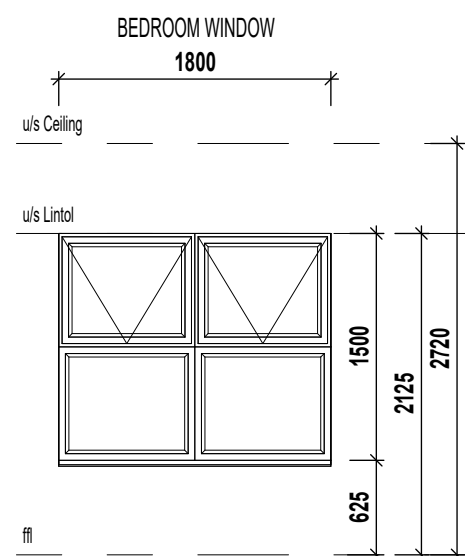

1 Bedroom - 1 Bathroom

SCALE 1:50

B6

ELECTRICAL LEGEND

- | | | |
|--|---|----------------------|
| ● Surface Mounted LED Fitting | ⚡ Single Plug Point (300mm Above FFL) | ⚡ Distribution Board |
| ⊕ External Wall Mounted LED Light Fitting | ⚡ Double Plug Point (300mm Above FFL) | 📺 TV Point |
| — LED Strip Light Fitting (u/s - Eye levels - Kitchen) | ⚡ Single Plug Point (150mm Above Counter) | 📶 Fibre / Data Point |
| 🔌 Single Light Switch | ⚡ Double Plug Point (150mm Above Counter) | 🔌 Inverter |
| 🔌 Double Light Switch | ⚡ Stove Isolator (Above Counter) | |
| 🔌 Triple Light Switch | ⚡ Extractor Plug (High Level) | |
| 🔌 Two-Way Light Switch | | |

AREA TYPE B6

Floor Area	52.10 m ²
Cov Balcony	6.66 m ²
Total	58.77 m ²

* The areas are approximate and shall vary from the areas reflected on the sectional title plan

2025-06-02

Rev E