
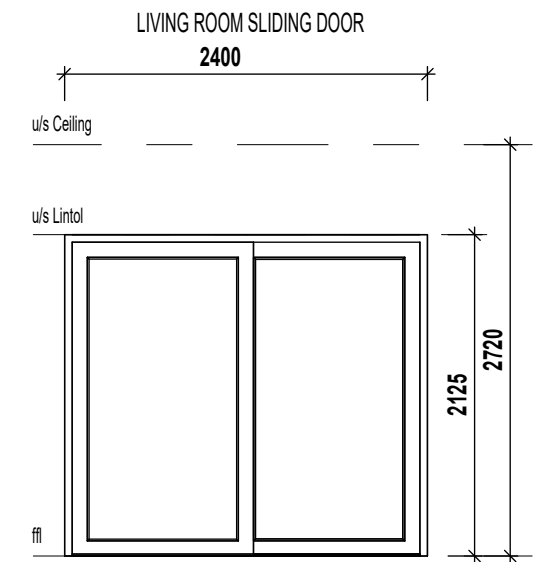
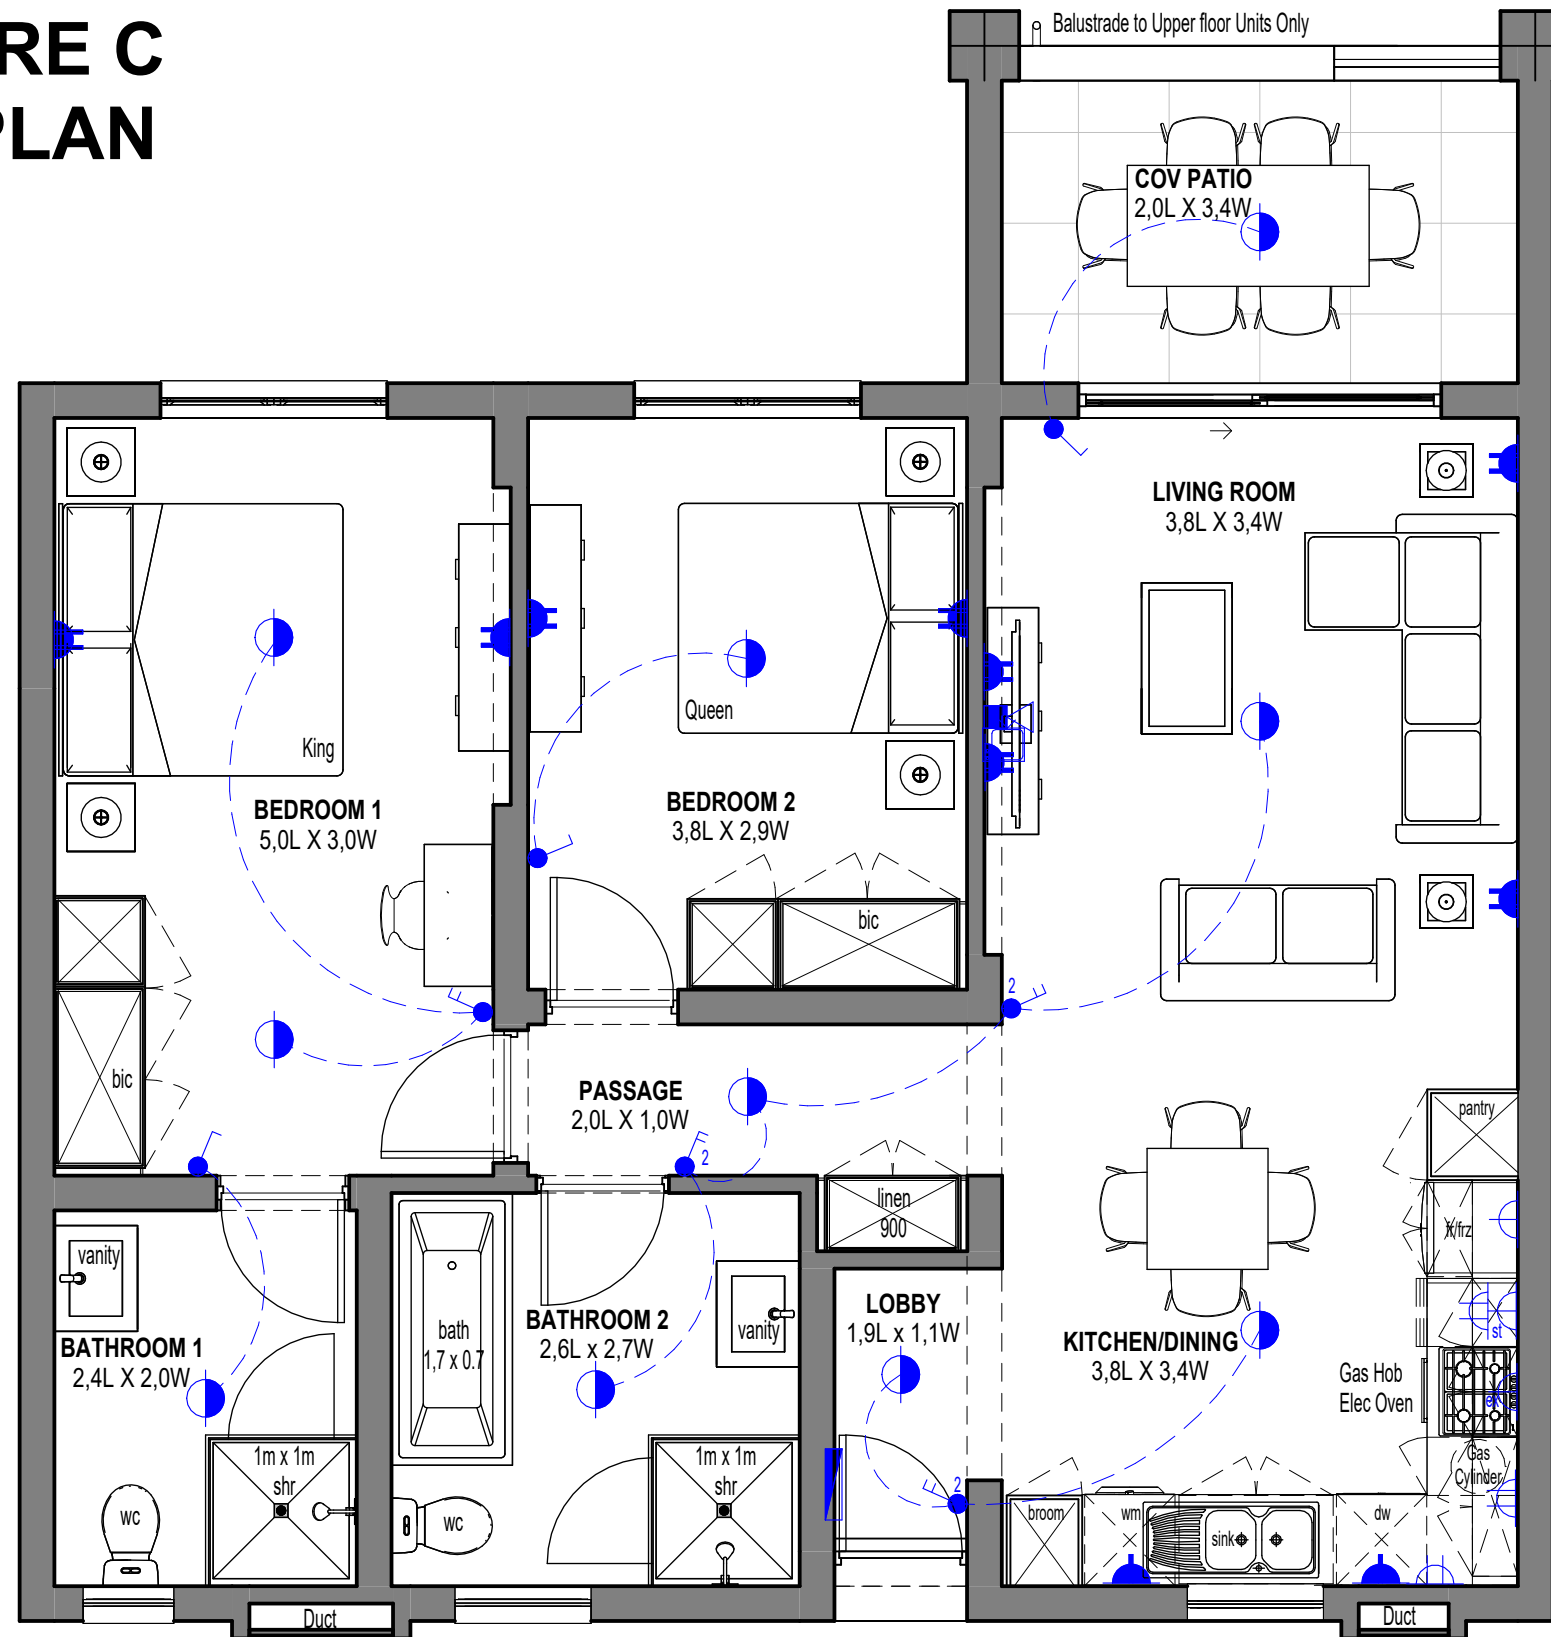


ANNEXURE C FLOOR PLAN

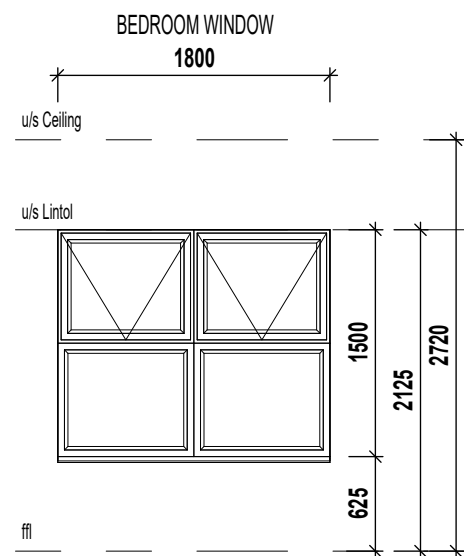

2 Bedroom - 2 Bathroom

SCALE 1:50

D8

ELECTRICAL LEGEND

- | | | |
|--|---|----------------------|
| ● Surface Mounted LED Fitting | ⚡ Single Plug Point (300mm Above FFL) | ⚡ Distribution Board |
| ⊕ External Wall Mounted LED Light Fitting | ⚡ Double Plug Point (300mm Above FFL) | ⓧ TV Point |
| — LED Strip Light Fitting (u/s - Eye levels - Kitchen) | ⚡ Single Plug Point (150mm Above Counter) | ⓧ Fibre / Data Point |
| ⚡ Single Light Switch | ⚡ Double Plug Point (150mm Above Counter) | ⓧ Inverter |
| ⚡ Double Light Switch | ⚡ Stove Isolator (Above Counter) | |
| ⚡ Triple Light Switch | ⚡ Extractor Plug (High Level) | |
| ⚡ Two-Way Light Switch | | |

AREA TYPE D8

Floor Area	82.81 m ²
Cov Balcony	8.64 m ²
Total	91.45 m ²

* The areas are approximate and shall vary from the areas reflected on the sectional title plan

2025-06-02

Rev E